

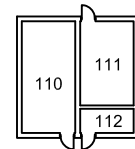
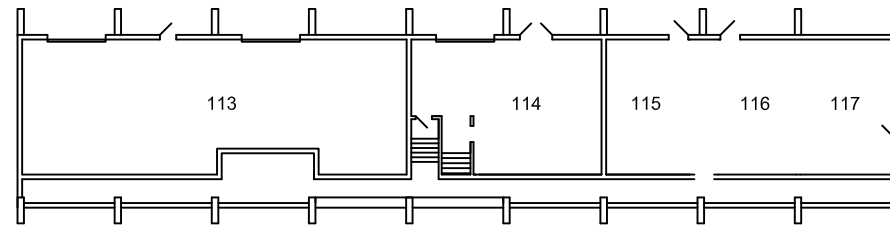



EAST SIDE

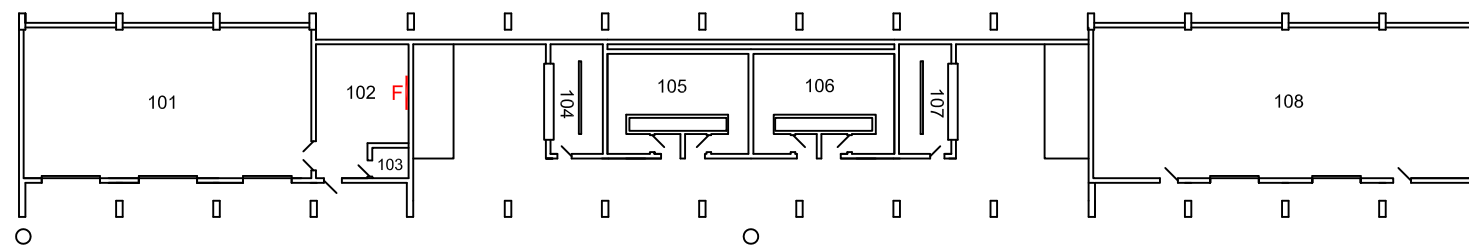

TICKET BOOTH

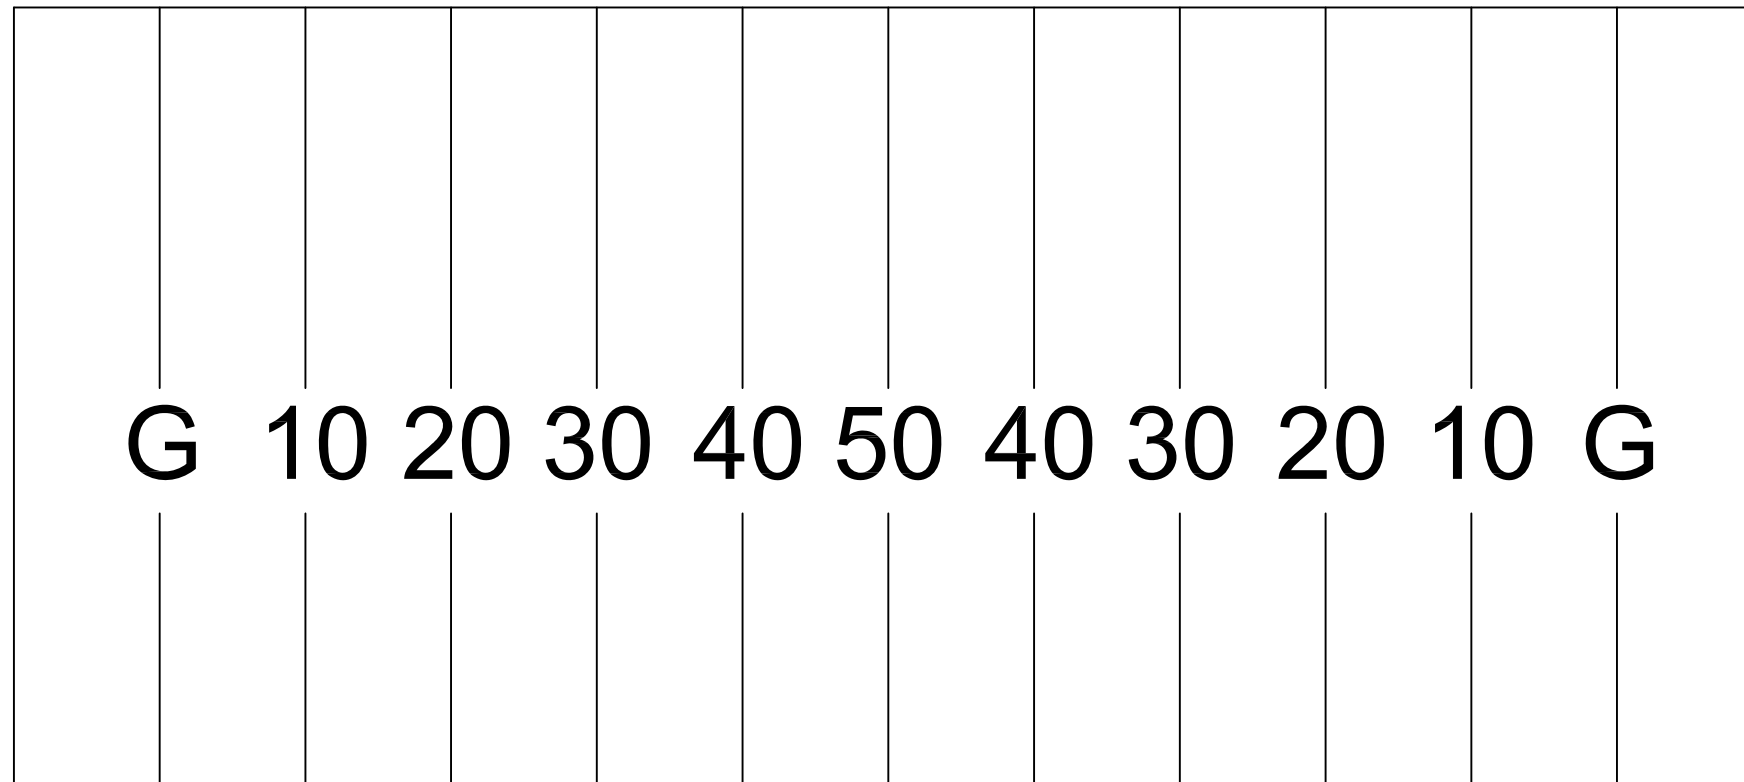

 WEST SIDE



SCALE: 1" = 40'

A - Annunciator Panel
 F - Fire Panel
 R - Sprinkler Riser Valve

MINNESOTA STATE UNIVERSITY,
 MANKATO
 FACILITIES MANAGEMENT



Blakeslee Stadium Ground
 Scale: 1"=40' Date: 10/01/2012
 File: Blakeslee Stadium
 Drawn By: Robin Guise