

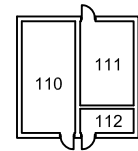
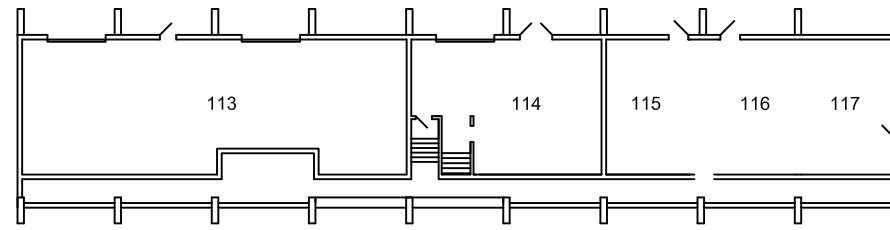



EAST SIDE

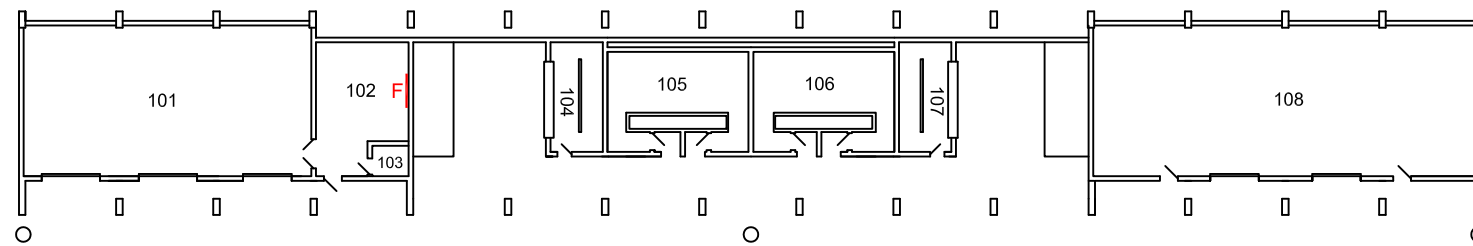

TICKET BOOTH

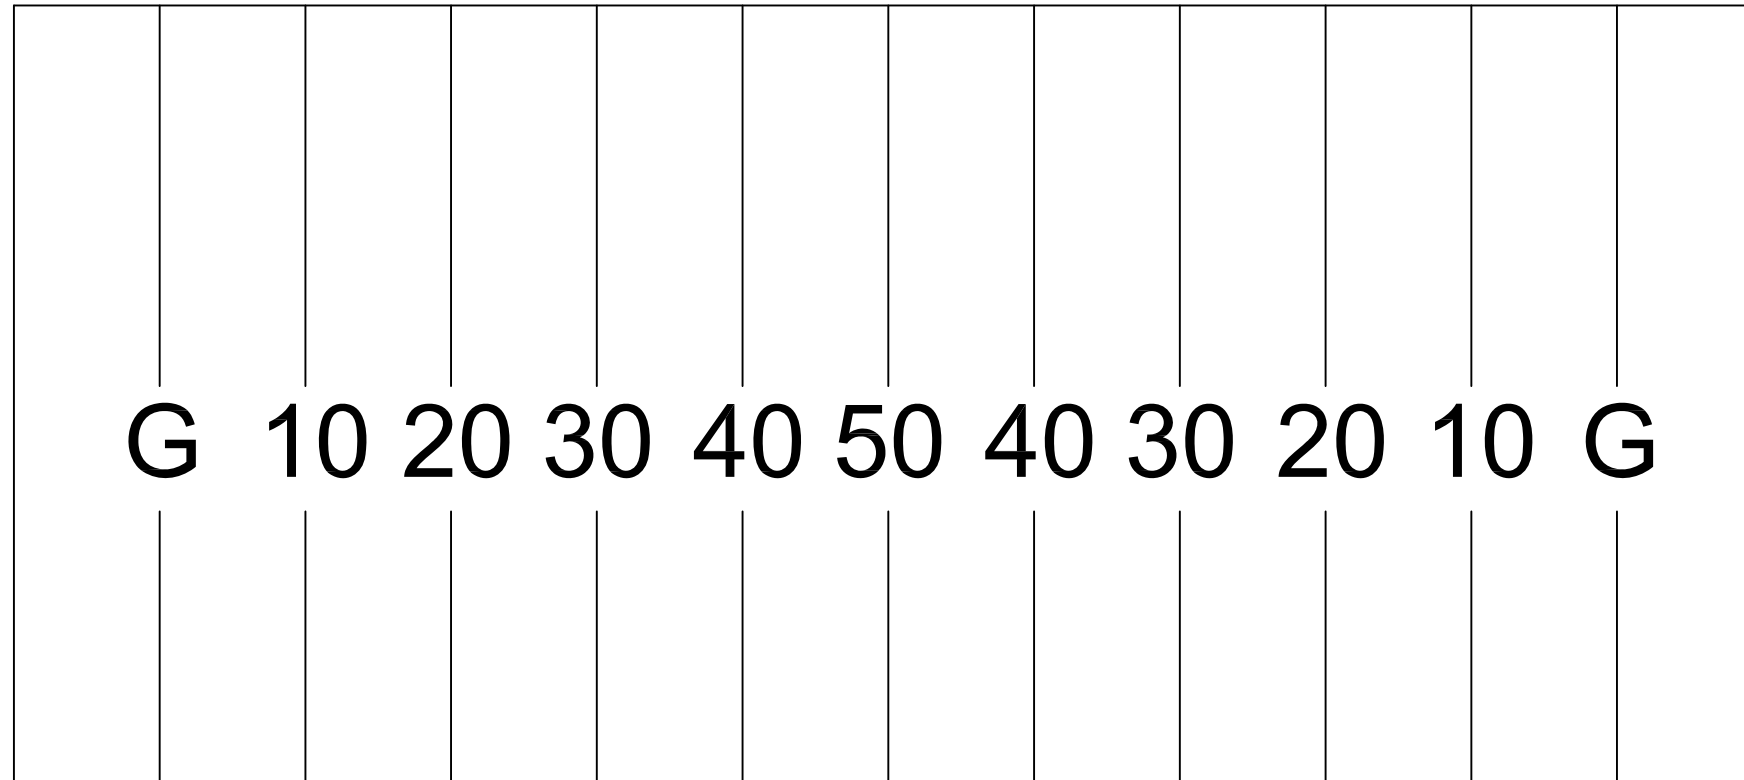

 WEST SIDE



SCALE: 1" = 40'

A - Annunciator Panel  
 F - Fire Panel  
 R - Sprinkler Riser Valve

MINNESOTA STATE UNIVERSITY,  
 MANKATO  
 FACILITIES MANAGEMENT



Blakeslee Stadium Ground  
 Scale: 1"=40'      Date: 10/01/2012  
 File: Blakeslee Stadium  
 Drawn By: Robin Guise